



GROUND PLAN

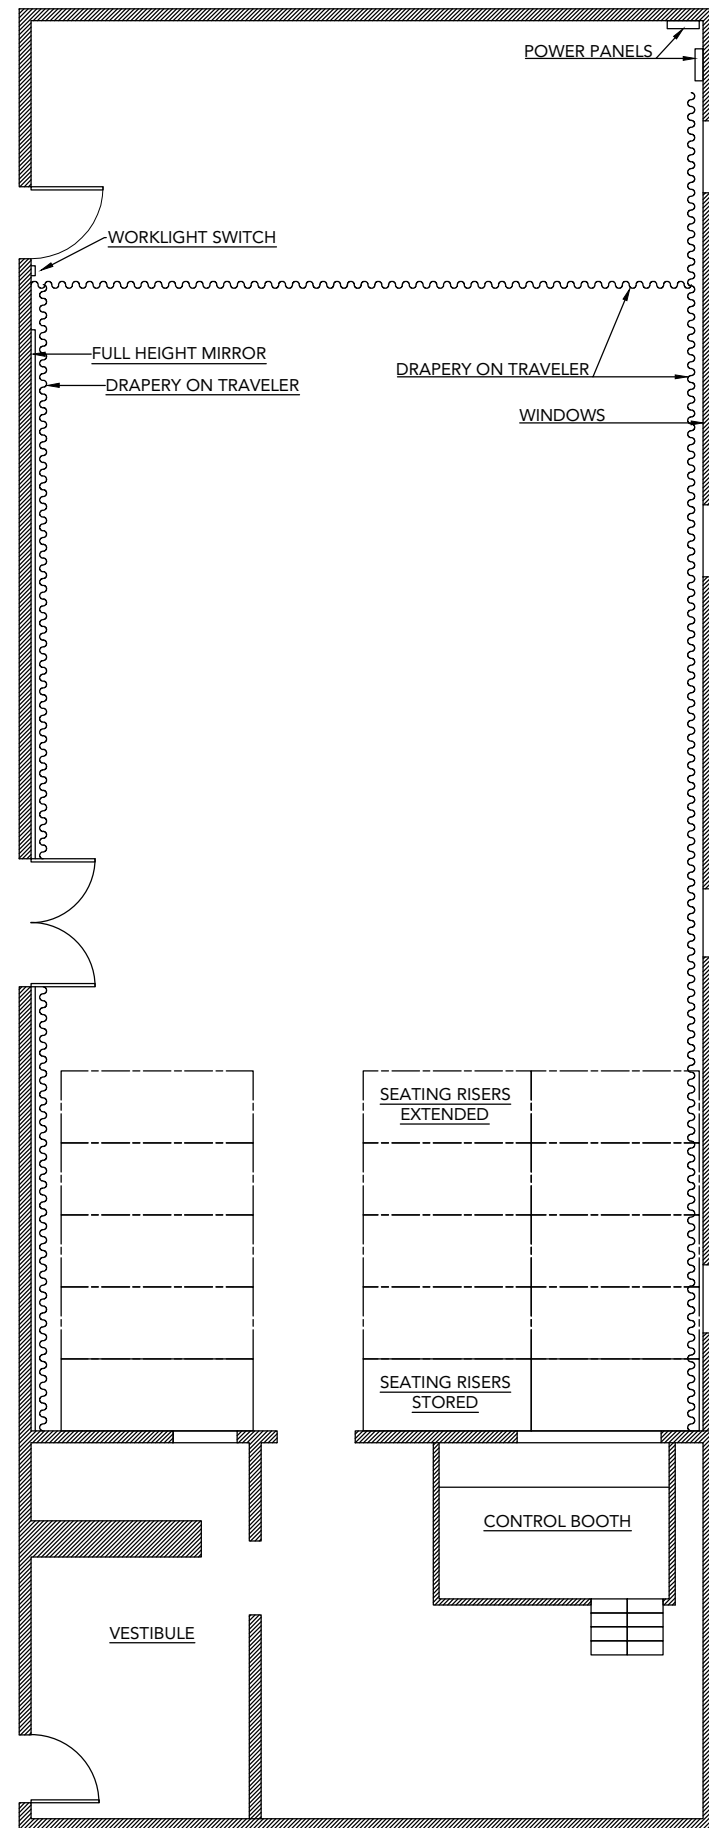

LIGHTING GRID AND REFLECTED CEILING PLAN

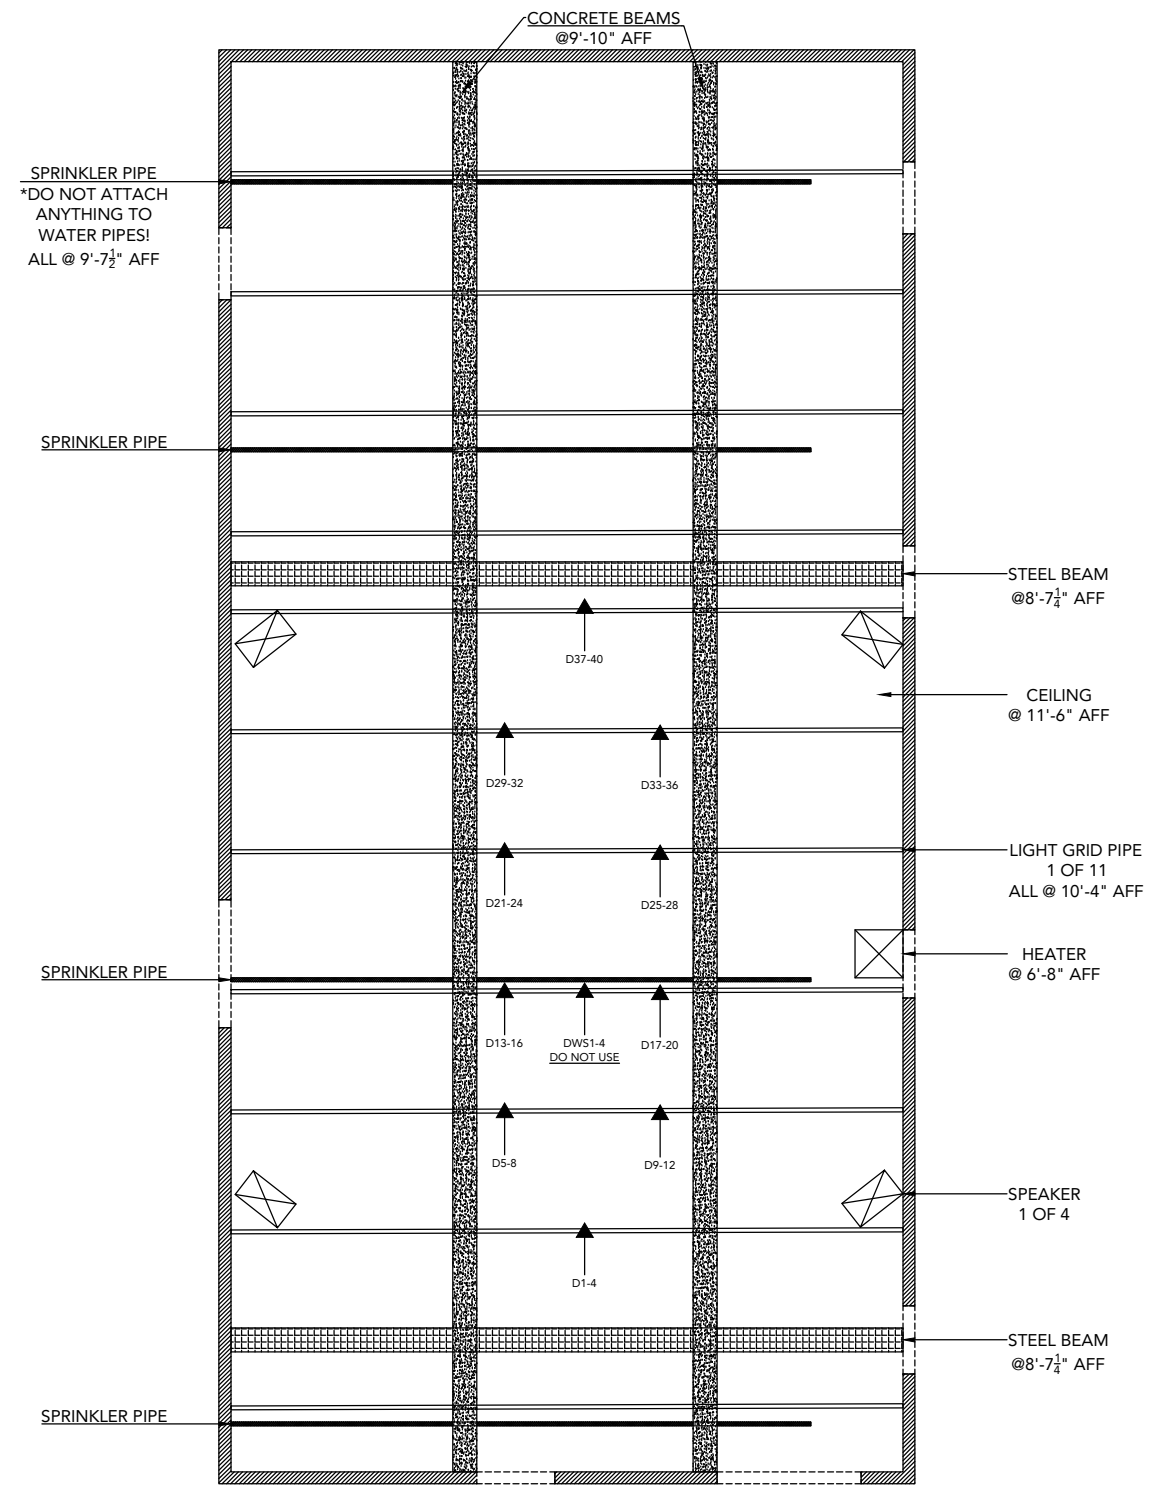

THEATRE 4	
GROUND & CEILING PLAN	
DRAFTED: RADIN	PLATE #:
	1.00
PLATE SIZE: 11X17	
2/15/2017 1:51 AM	SCALE: 1/8" = 1'-0"